


ALL RIGHTS RESERVED

**LOWER FLOOR PLAN**


**PROPOSED STRUCTURE AT:**

**SCALE: 1/4" = 1'-0"**

<b>DRAWN BY:</b>	
<b>DATE:</b>	
<b>PAGE:</b>	

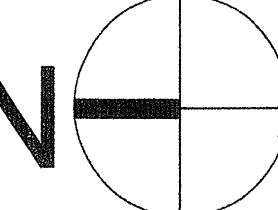**N**  **FLOOR PLAN**  
LOWER LEVEL

ALL RIGHTS RESERVED

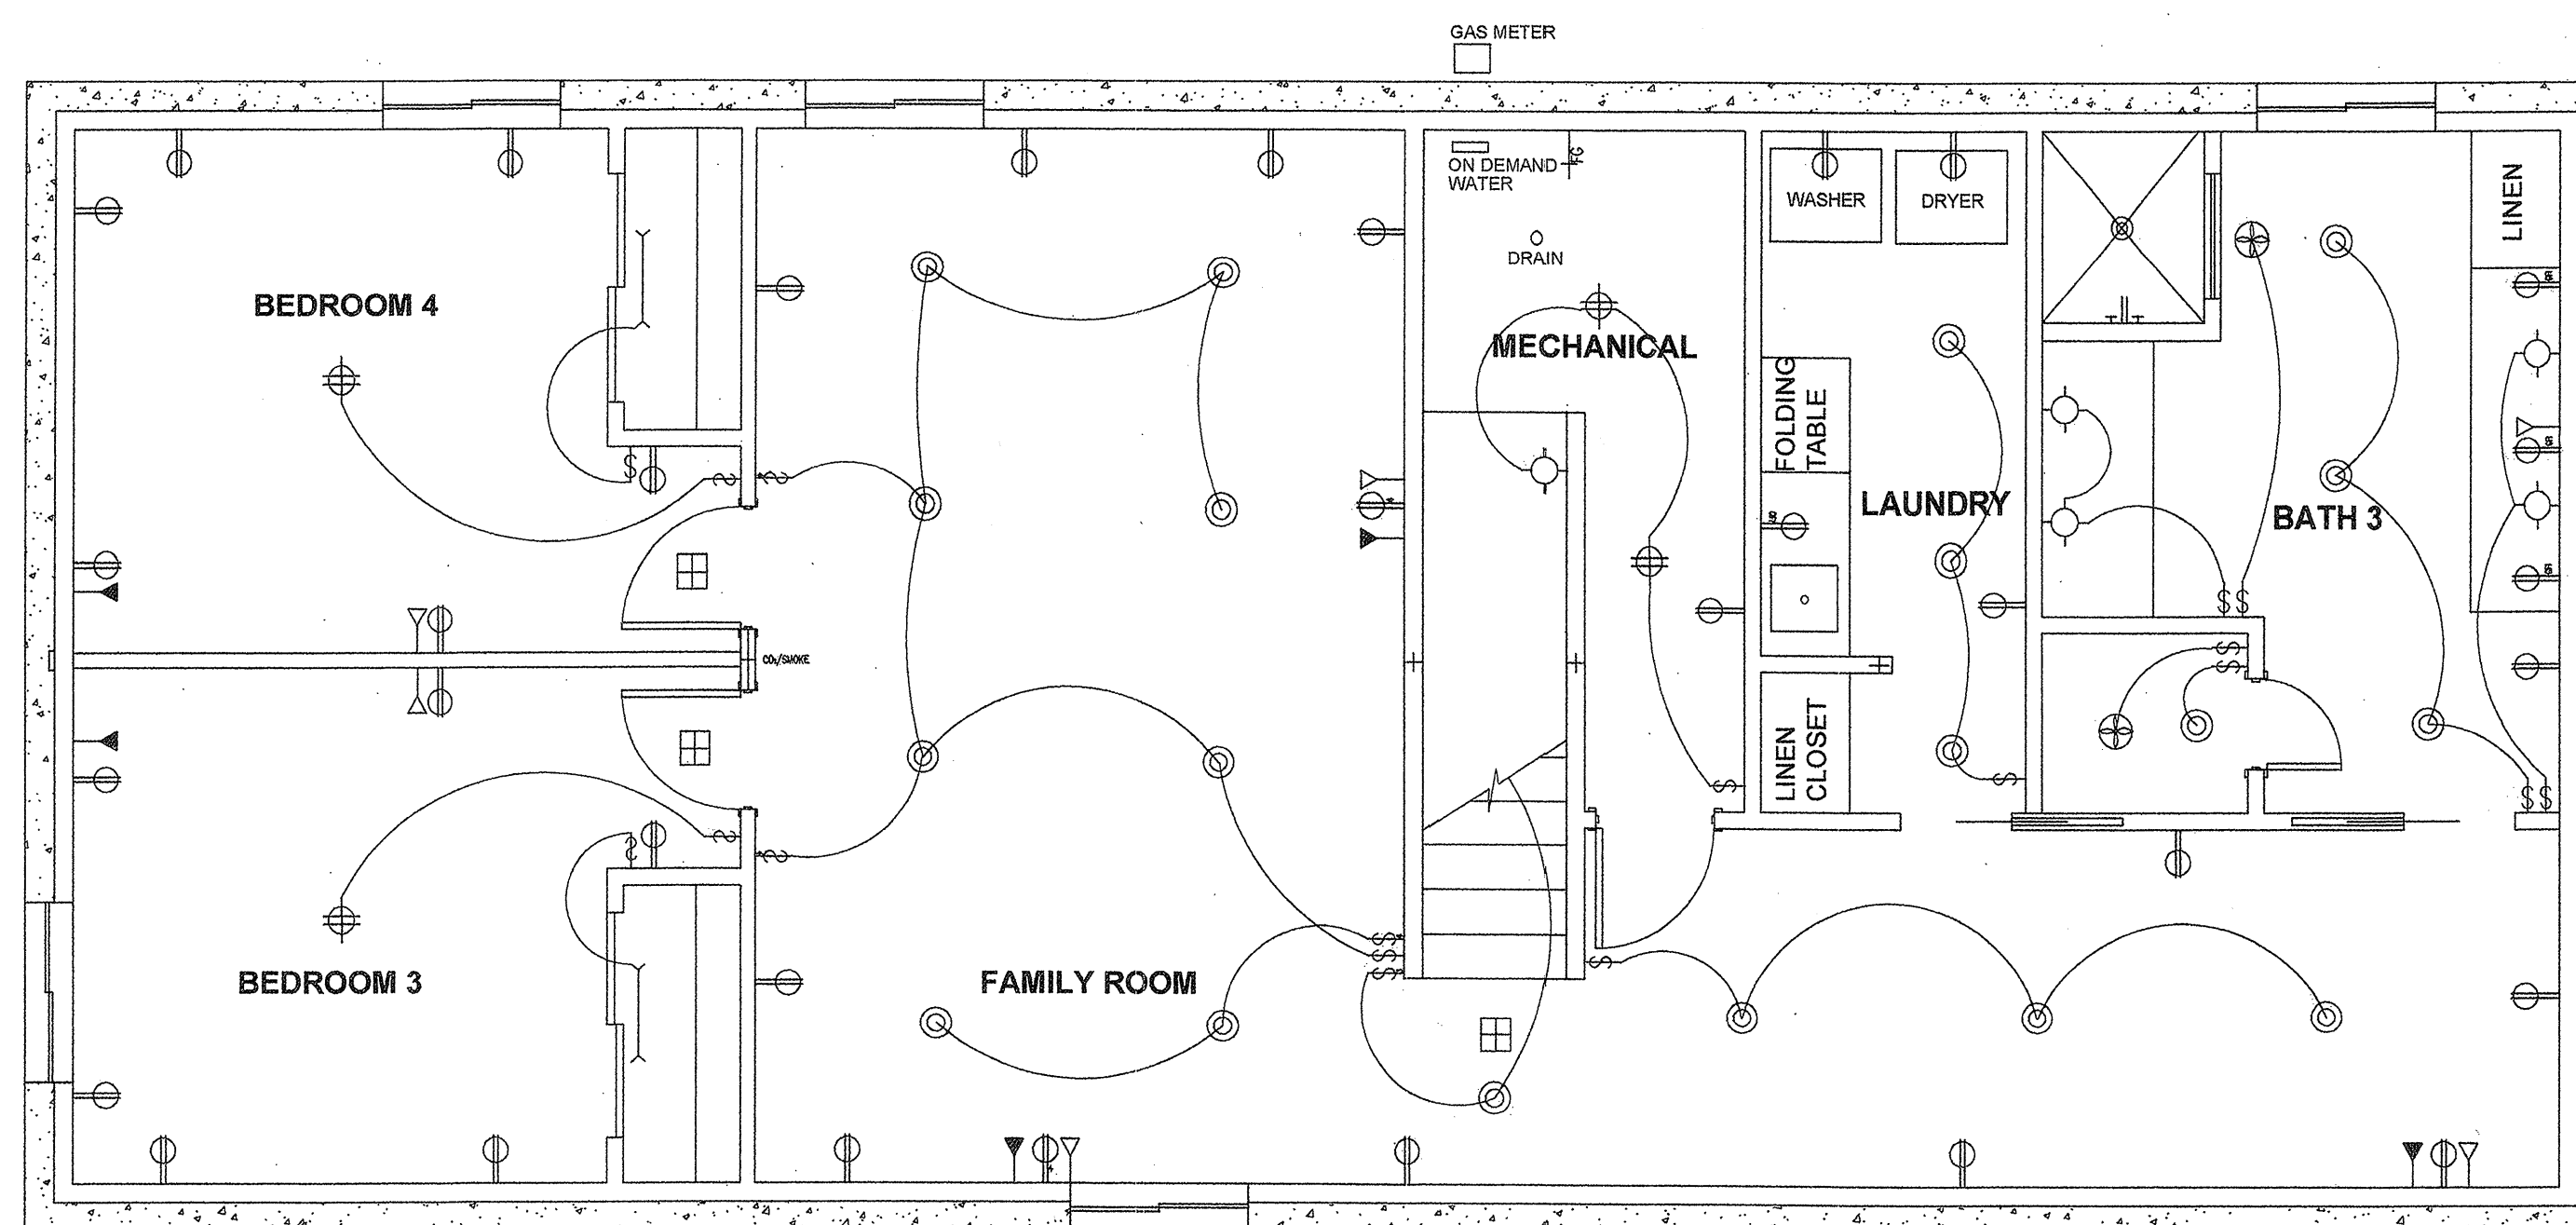

SYM.	LIGHTING LEGEND
⊙	RECESSED CAN
⊕	EXHAUST FAN
⊙	DUPLEX
⊕	SMOKE DETECTOR
⊙	WALL SWITCH SINGLE POLE
⊙	WALL SWITCH 3-WAY
⊙	CABLE JACK
⊙	PHONE JACK
⊙	SEMI-MOUNT FIXTURE
⊙	CEILING FAN
⊙	HOSE BIBB
⊙	WALL FIXTURE
⊙	FLOURESCENT LIGHT
⊙	PENDANT
⊙	CO <sub>2</sub> /SMOKE DETECTOR
⊙	THERMOSTAT
⊙	FLOOR OUTLET WITH COVER
⊙	WATERPROOF OUTLET
⊙	GFI DUPLEX

**ELECTRICAL FLOOR PLAN**  
LOWER LEVEL

LOWER ELECTRICAL PLAN

SCALE: 1/4" = 1'-0"

PROPOSED STRUCTURE AT:

DRAWN BY:

DATE: 12.08.09

PAGE: